

Table with 4 columns: QTY, DESIG., PART NO., DESCRIPTION. Lists parts for the control section, including terminal strips, relays, and sensors.









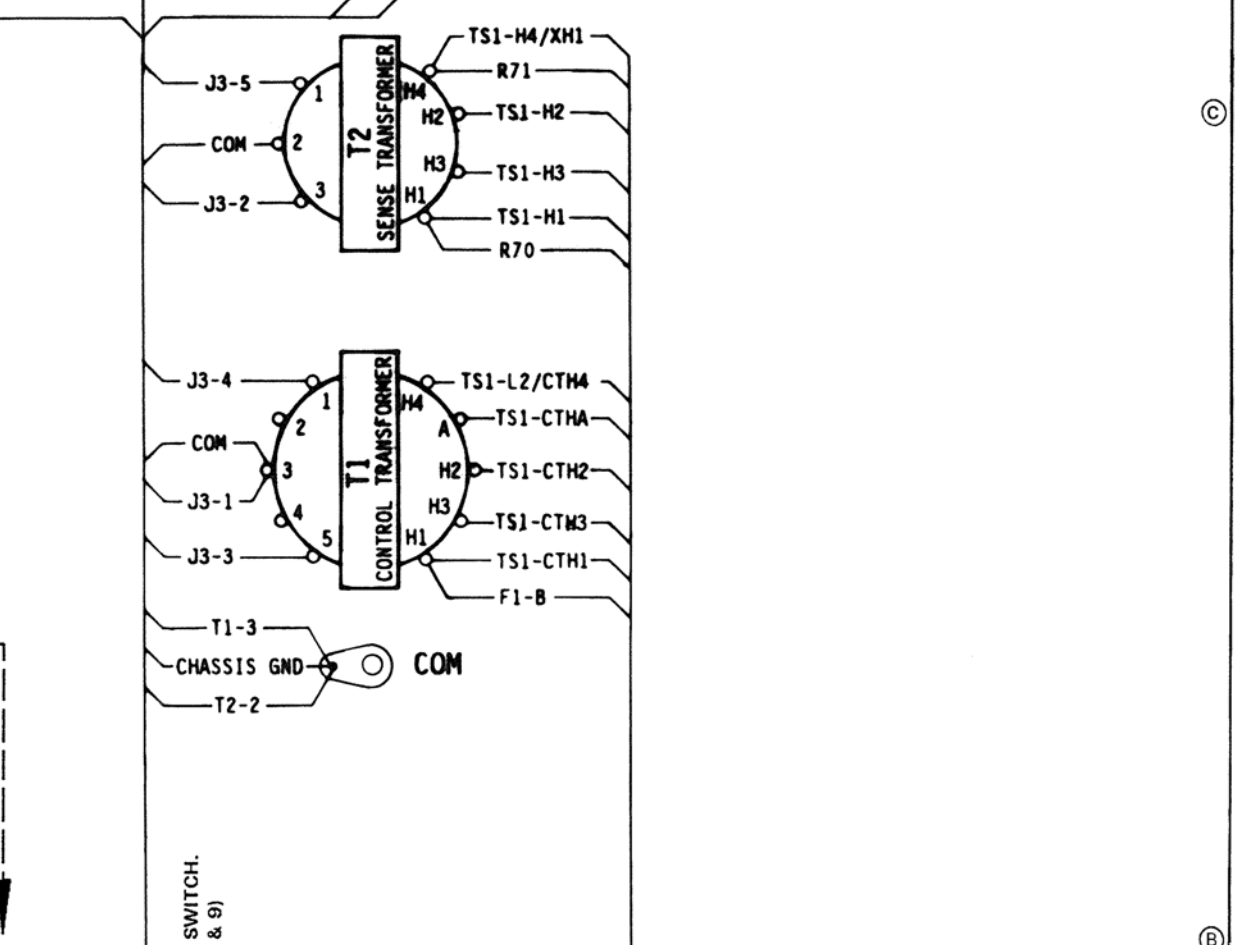





Table with 4 columns: QTY, DESIG., PART NO., DESCRIPTION. Lists parts for the contactor section, including thyristor contactors, relays, and sensors.

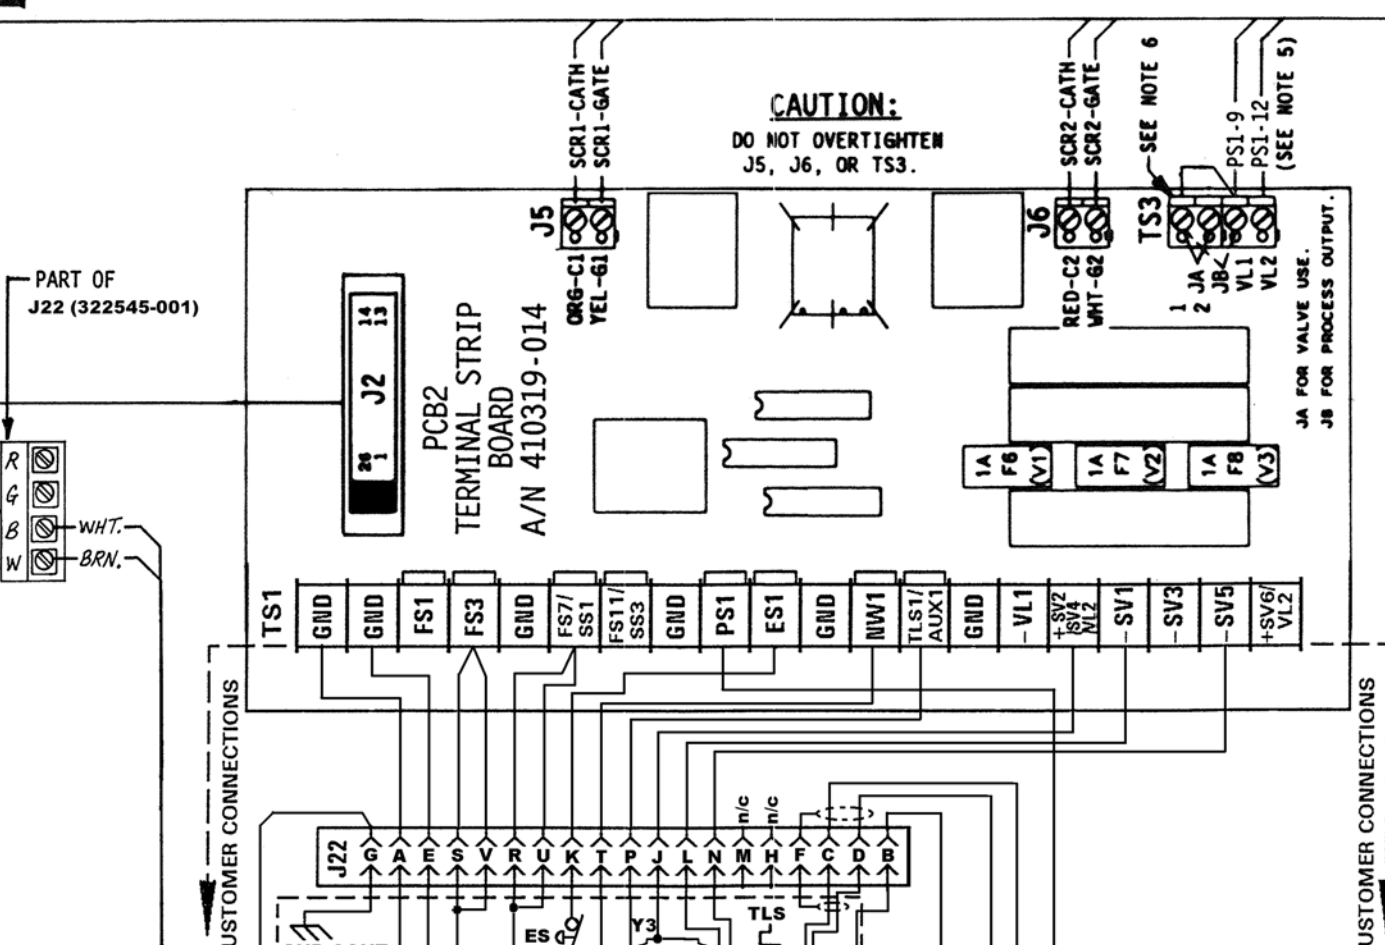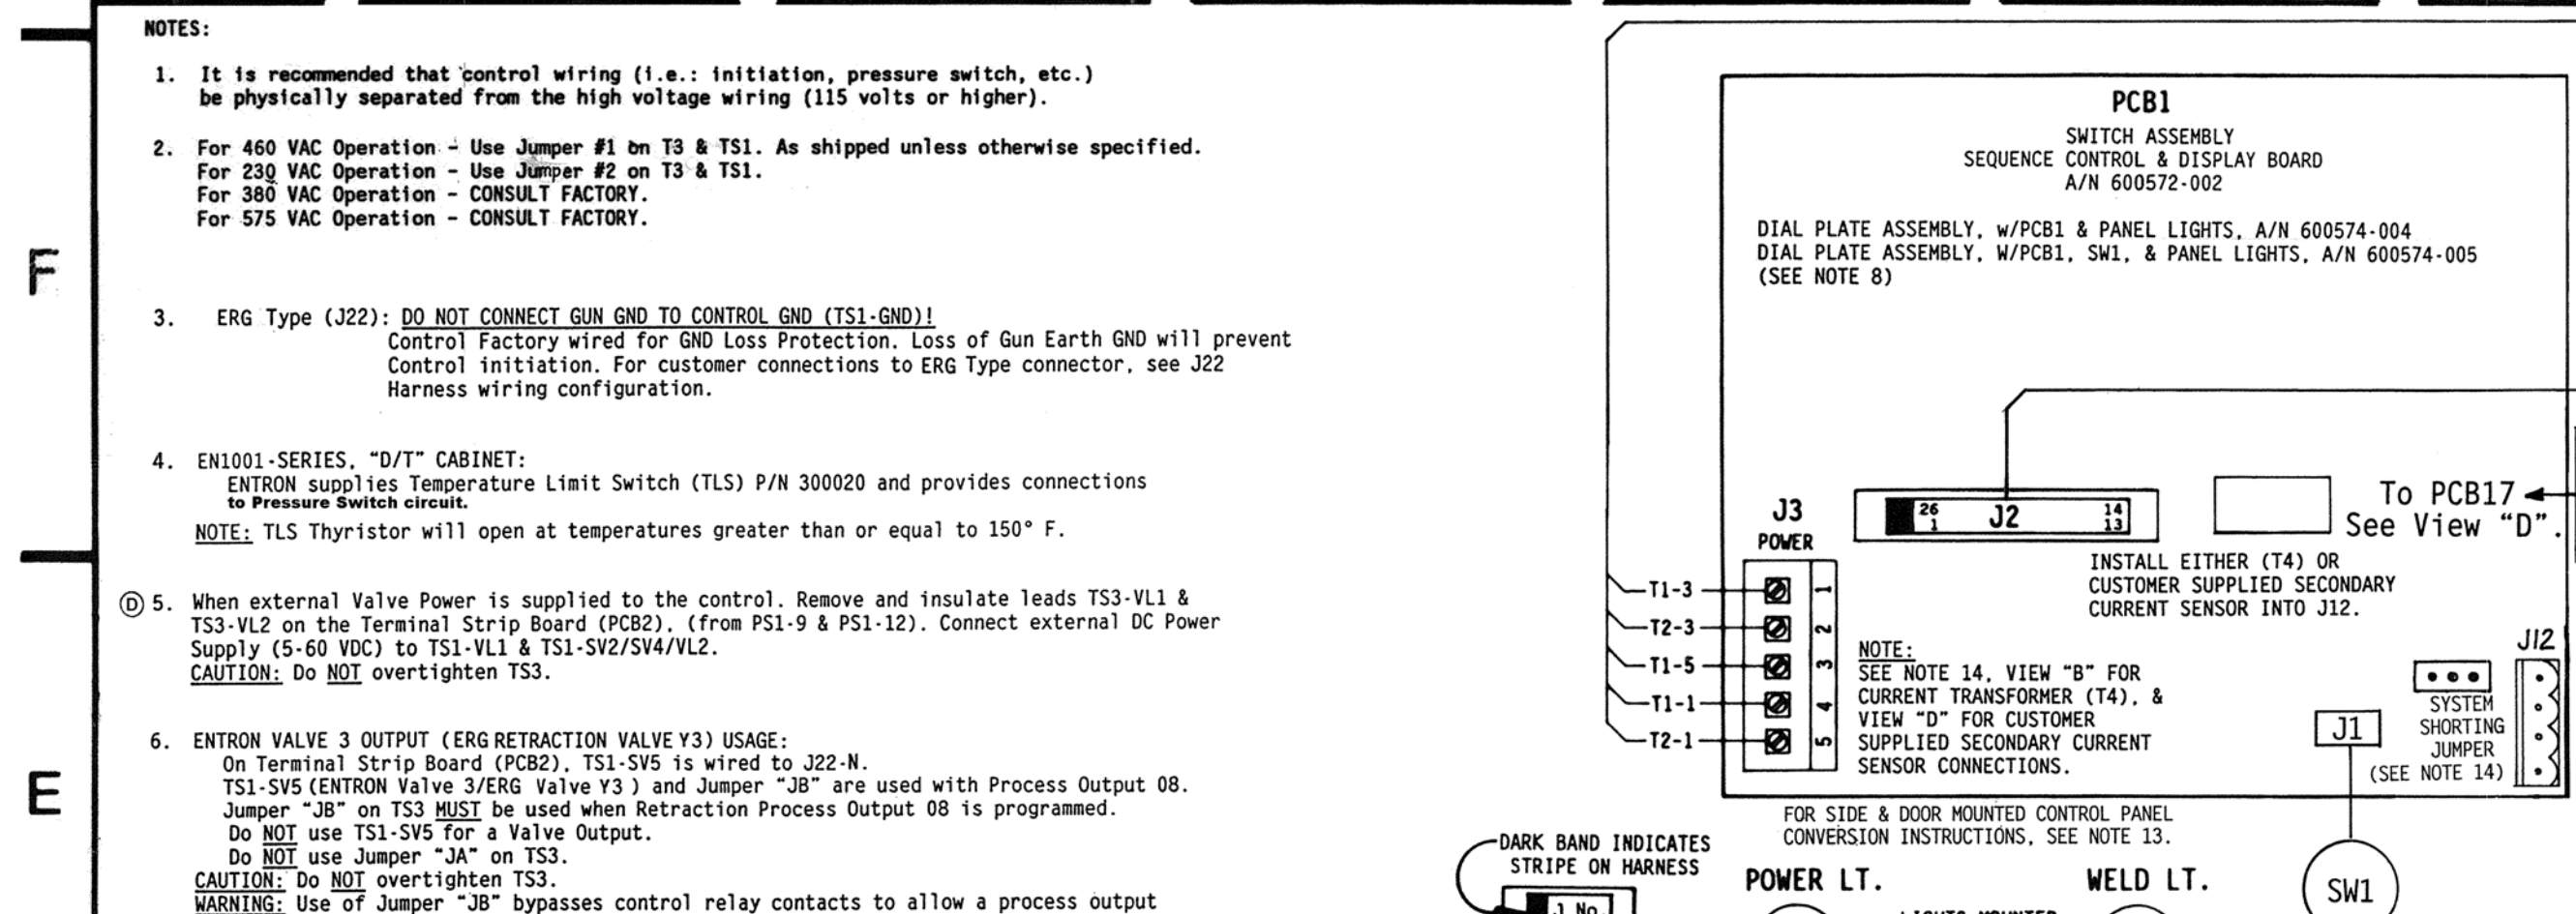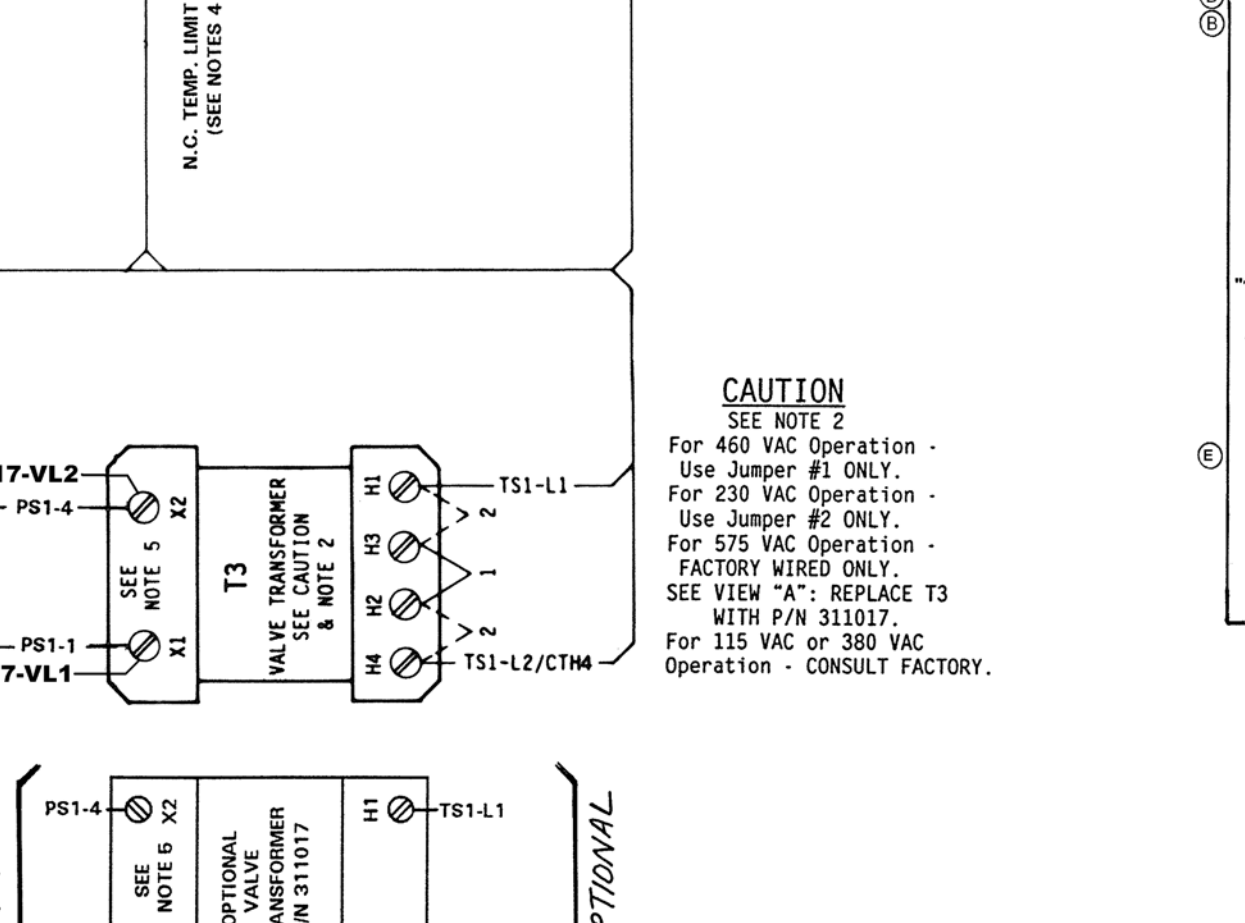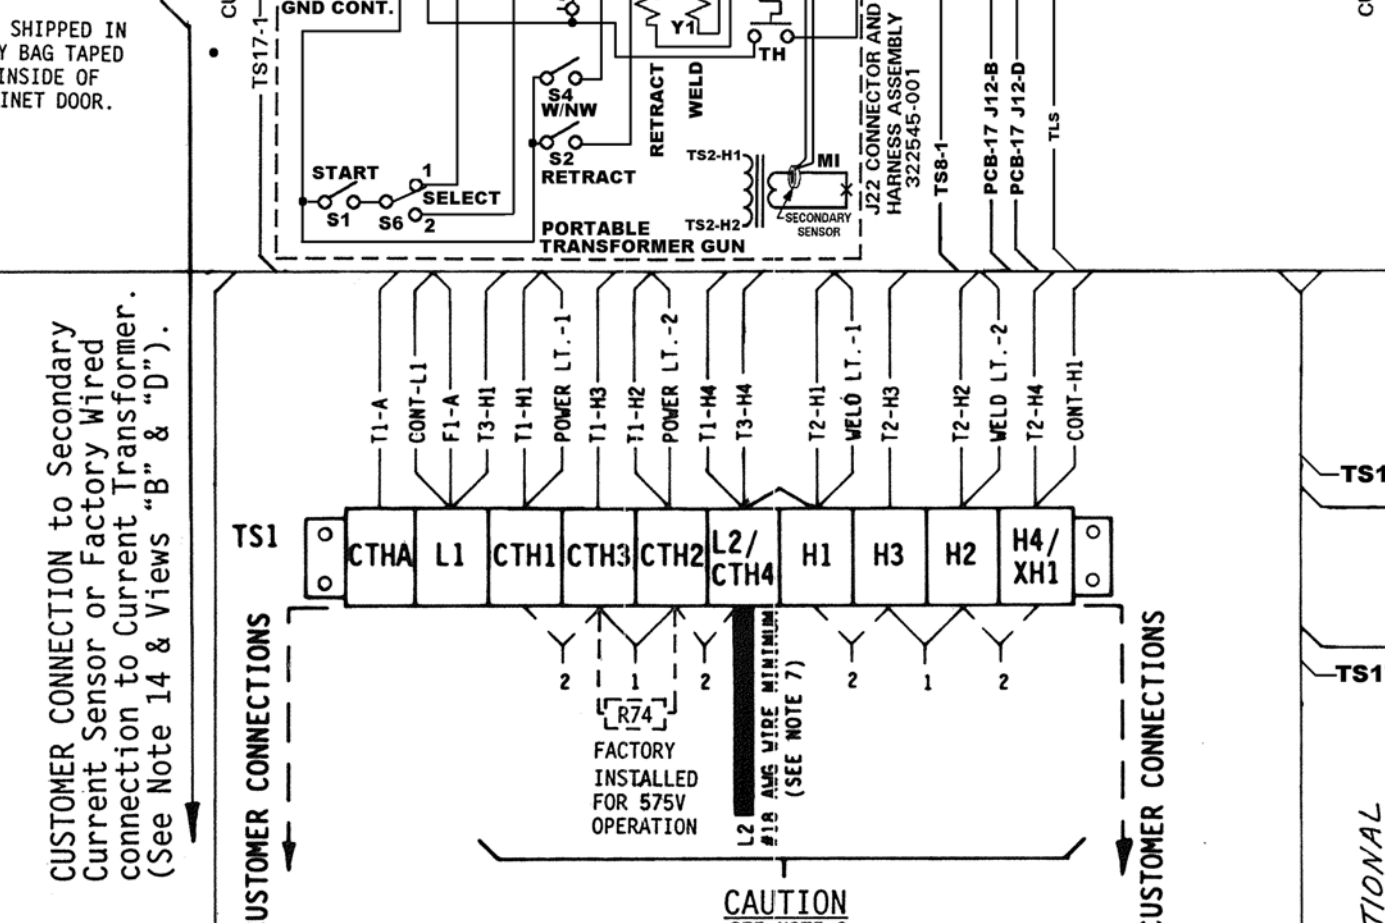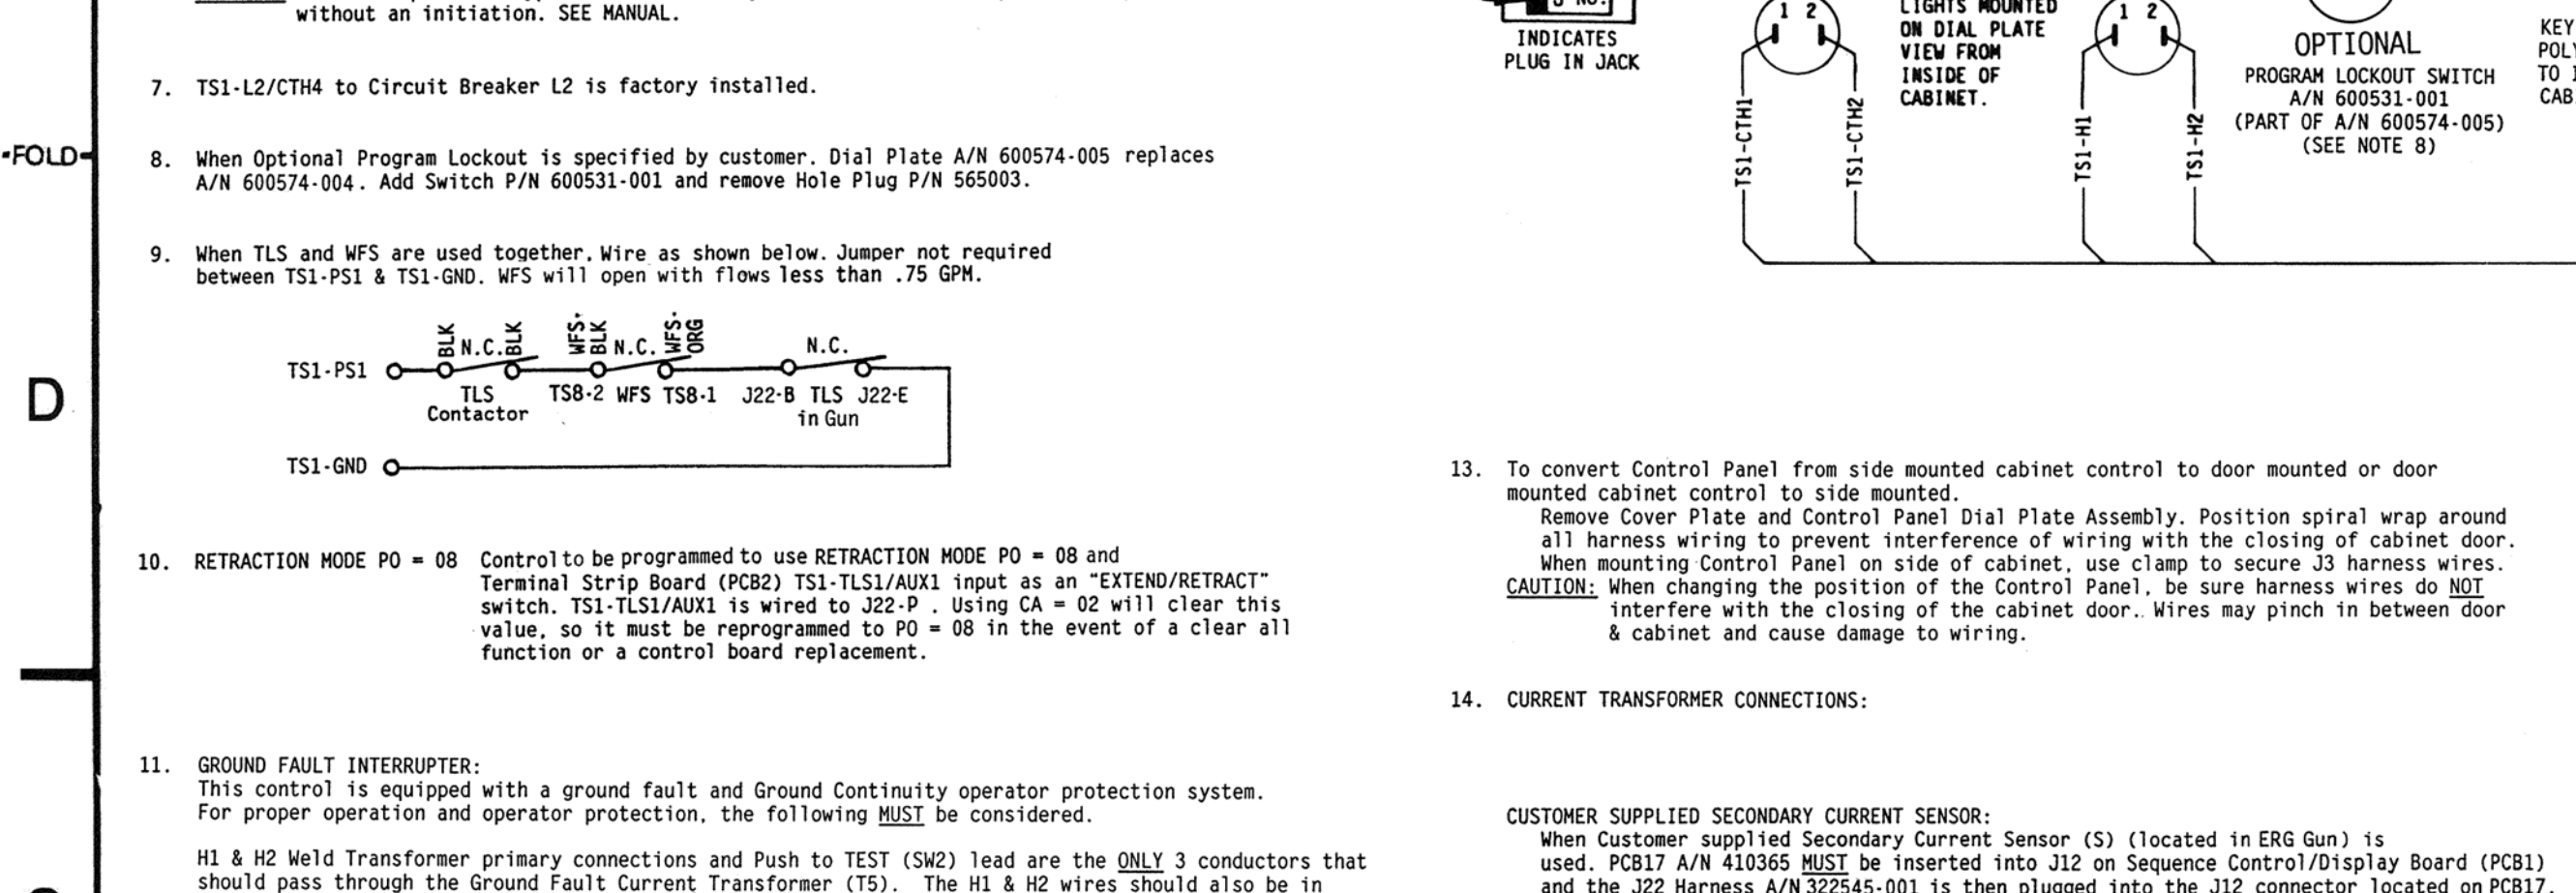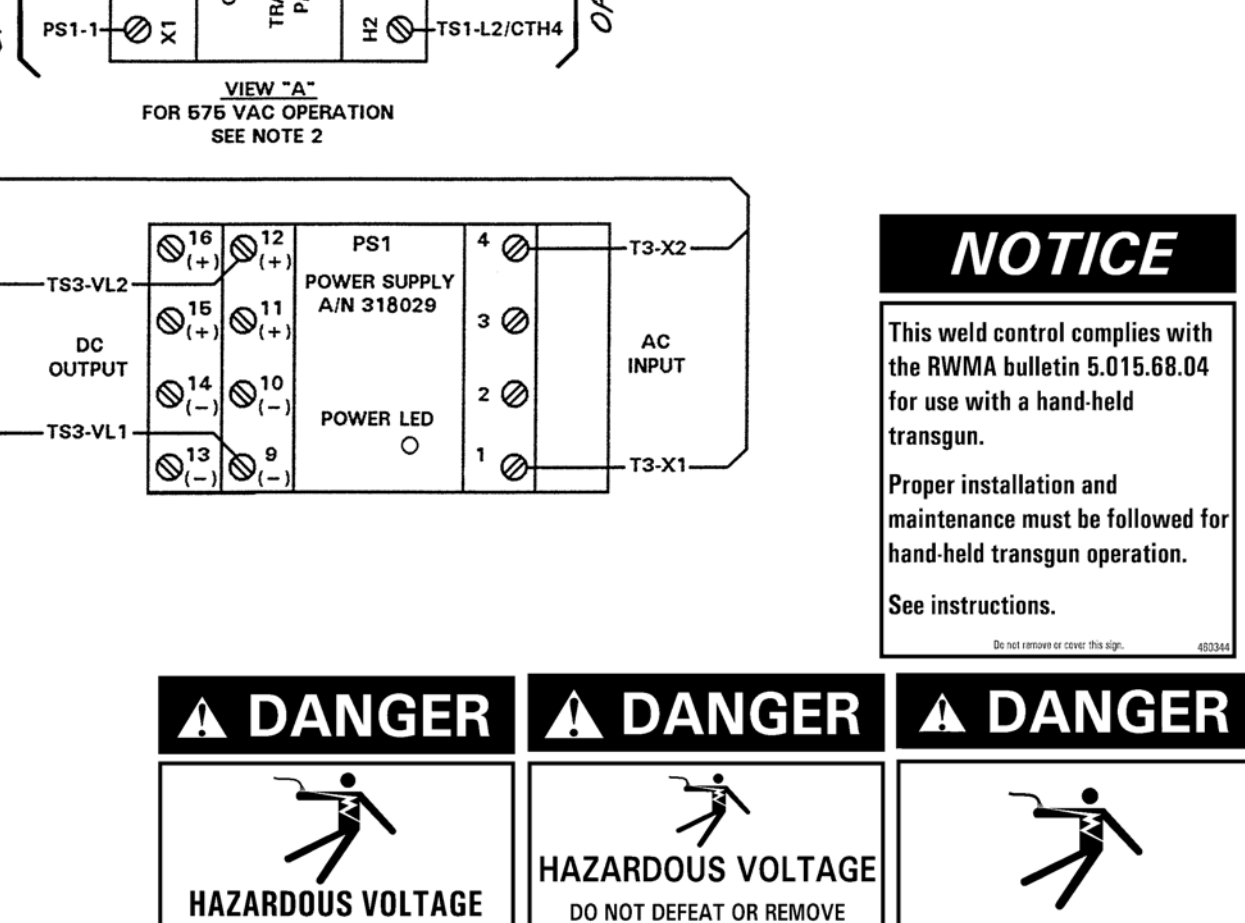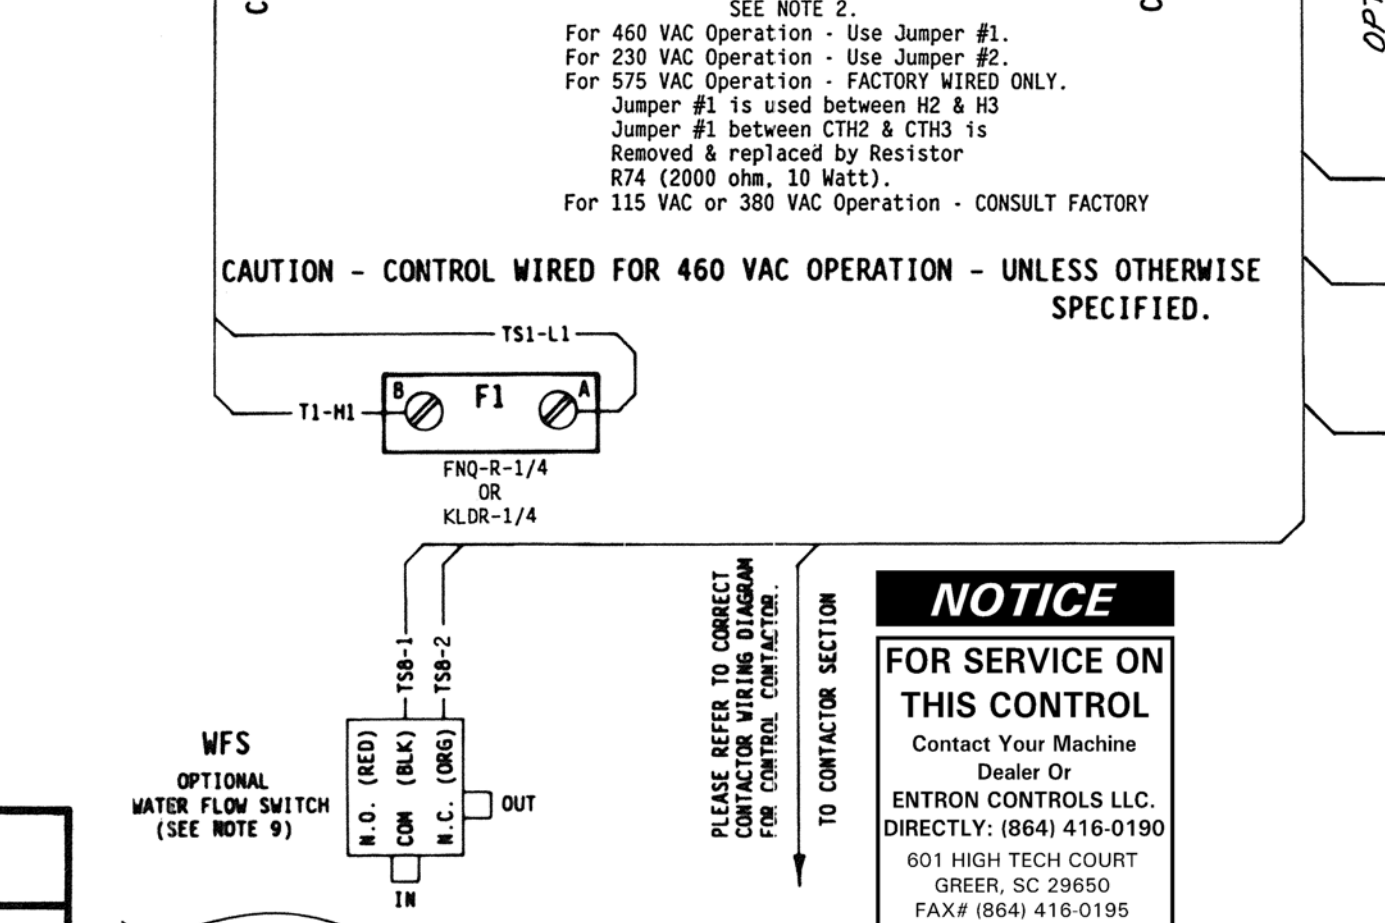

Substitution or addition of parts when 575V control is specified. Optional Keylock when specified by customer. Additional Thyristor Six inch (36") of hose. P/N 900045 and two (2) hose clamps. P/N 566010 are to be supplied. See Note 9.

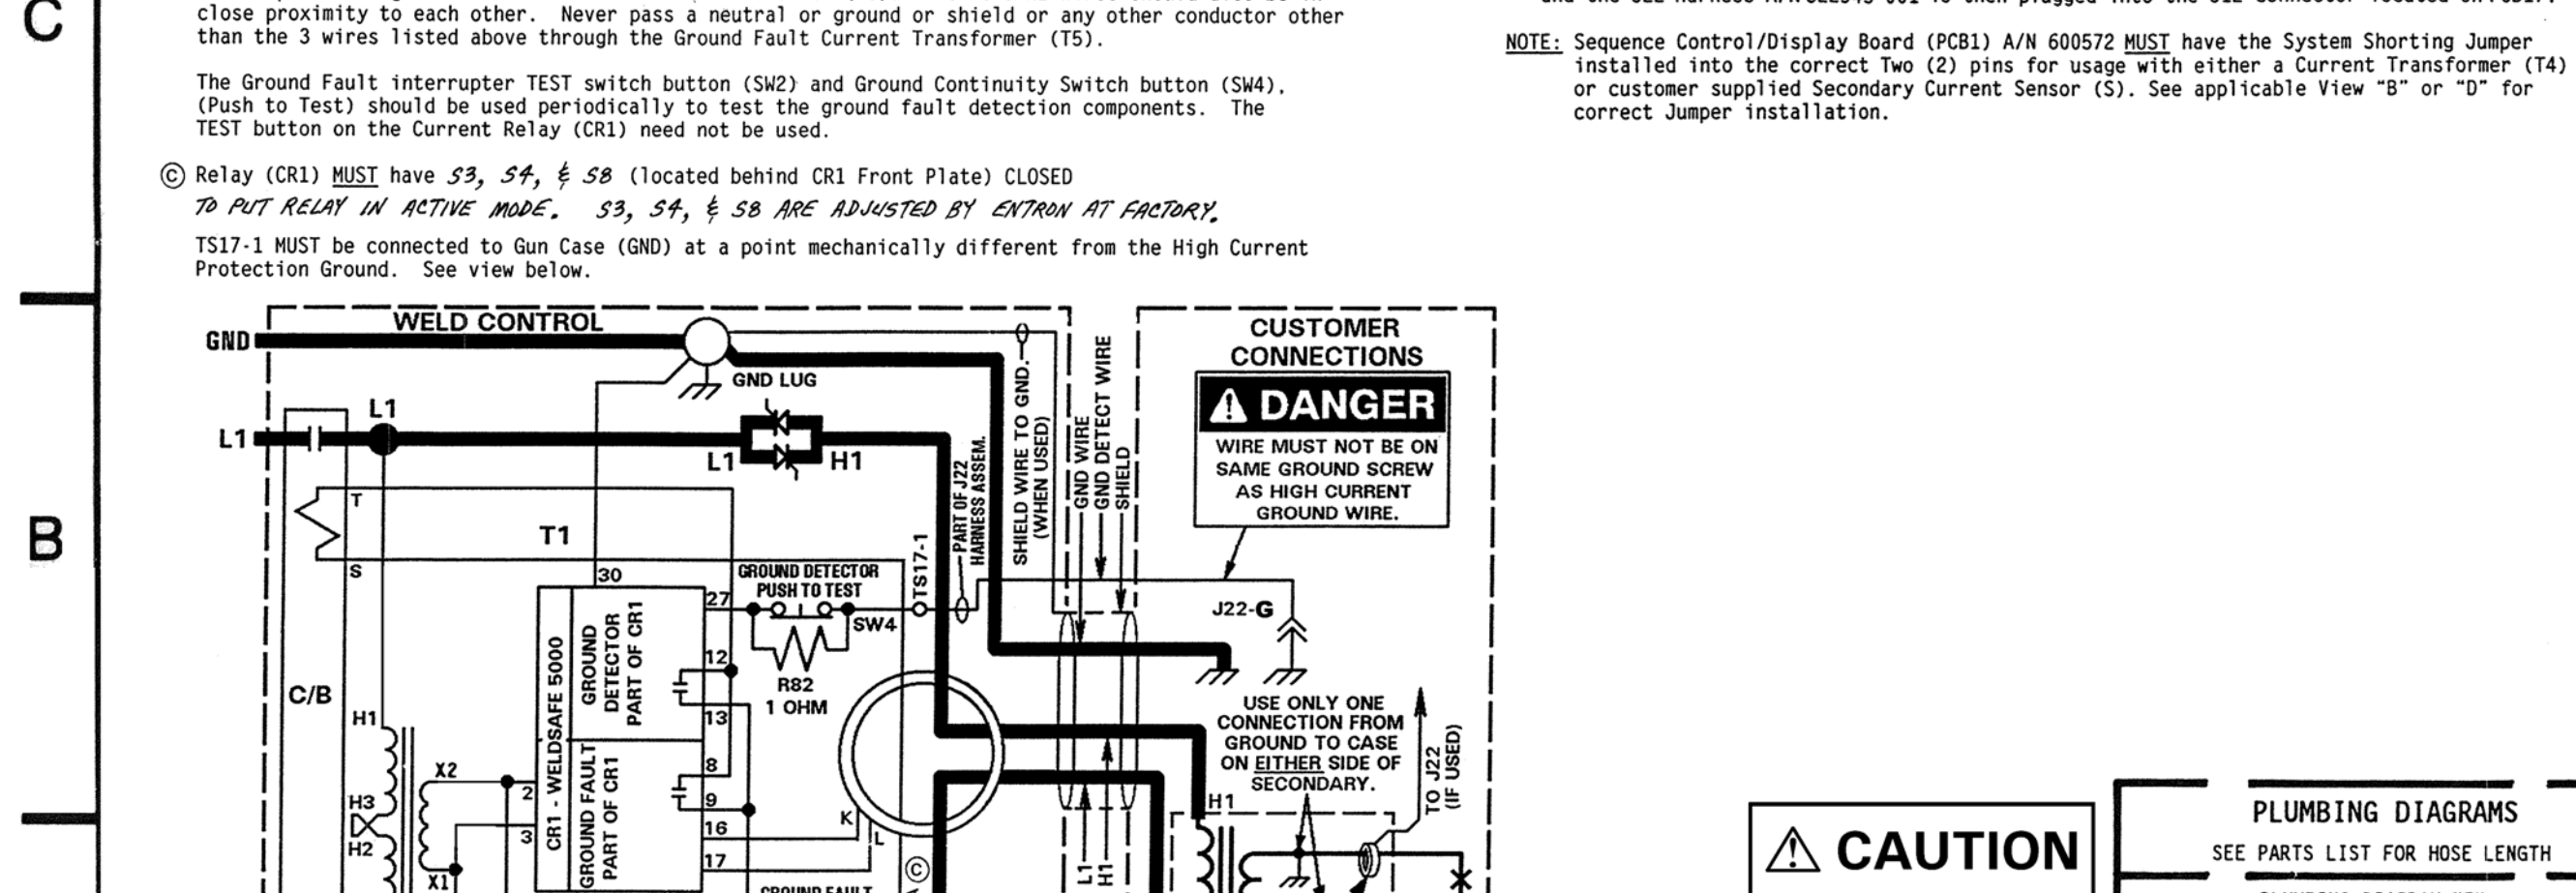

MANUFACTURING INSTRUCTIONS: See Drawing #600592 and 510247-002 for Mechanical Layout/Assembly of EN1001 "D/T" Cabinet. See Drawing #440366 for Inner Pack and use Carton #655016 for "D/T" Cabinet Packing Instructions. See Drawing #440437 for Circuit Breaker to L1 Contactor Cable connections. See Drawing #600526 for Layout/Assembly of Front Panel. See Drawing #440457 for Current Transformer Assembly.

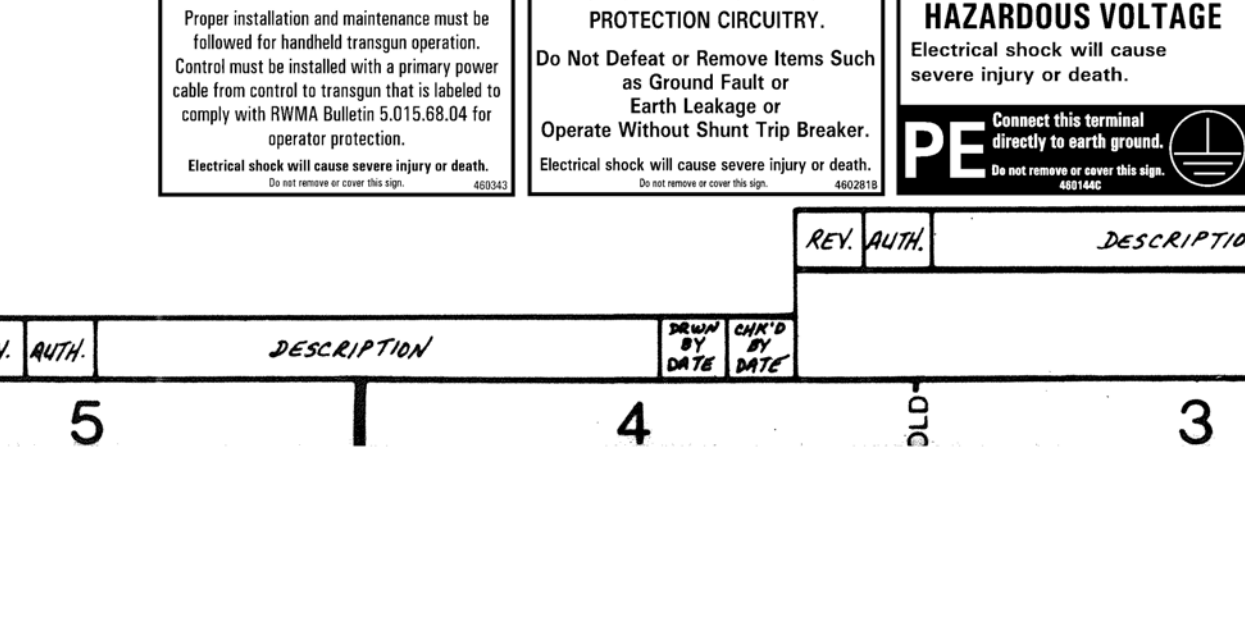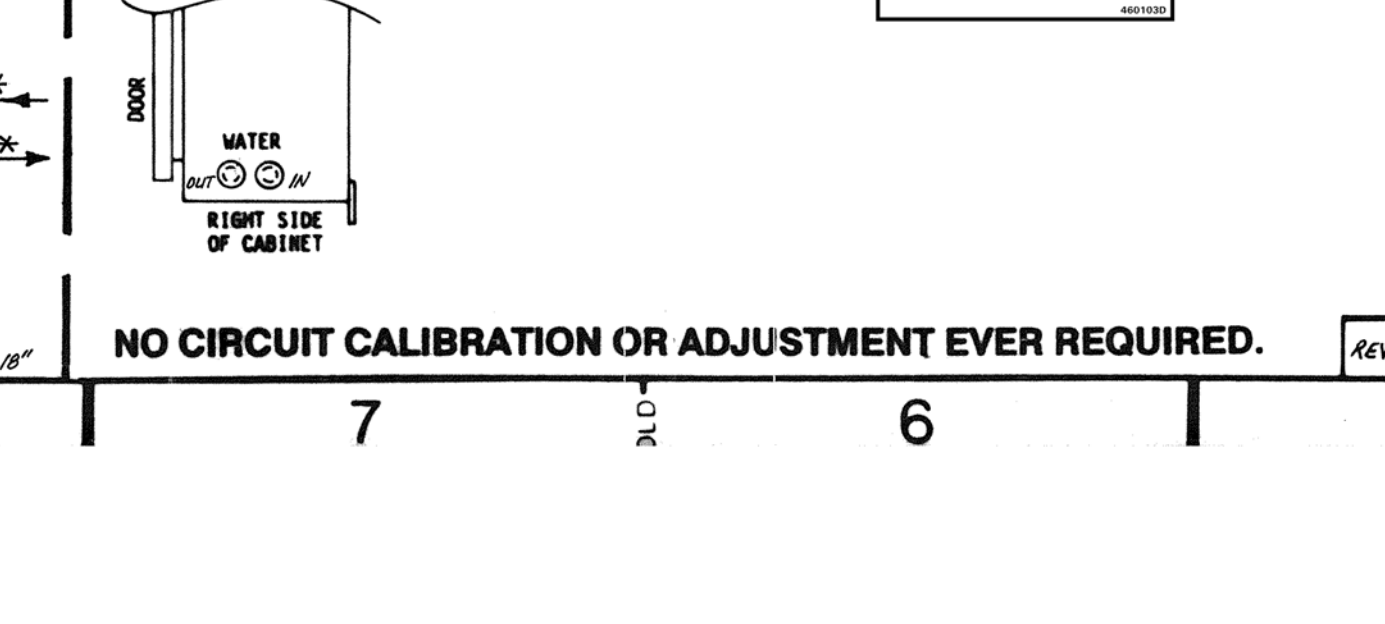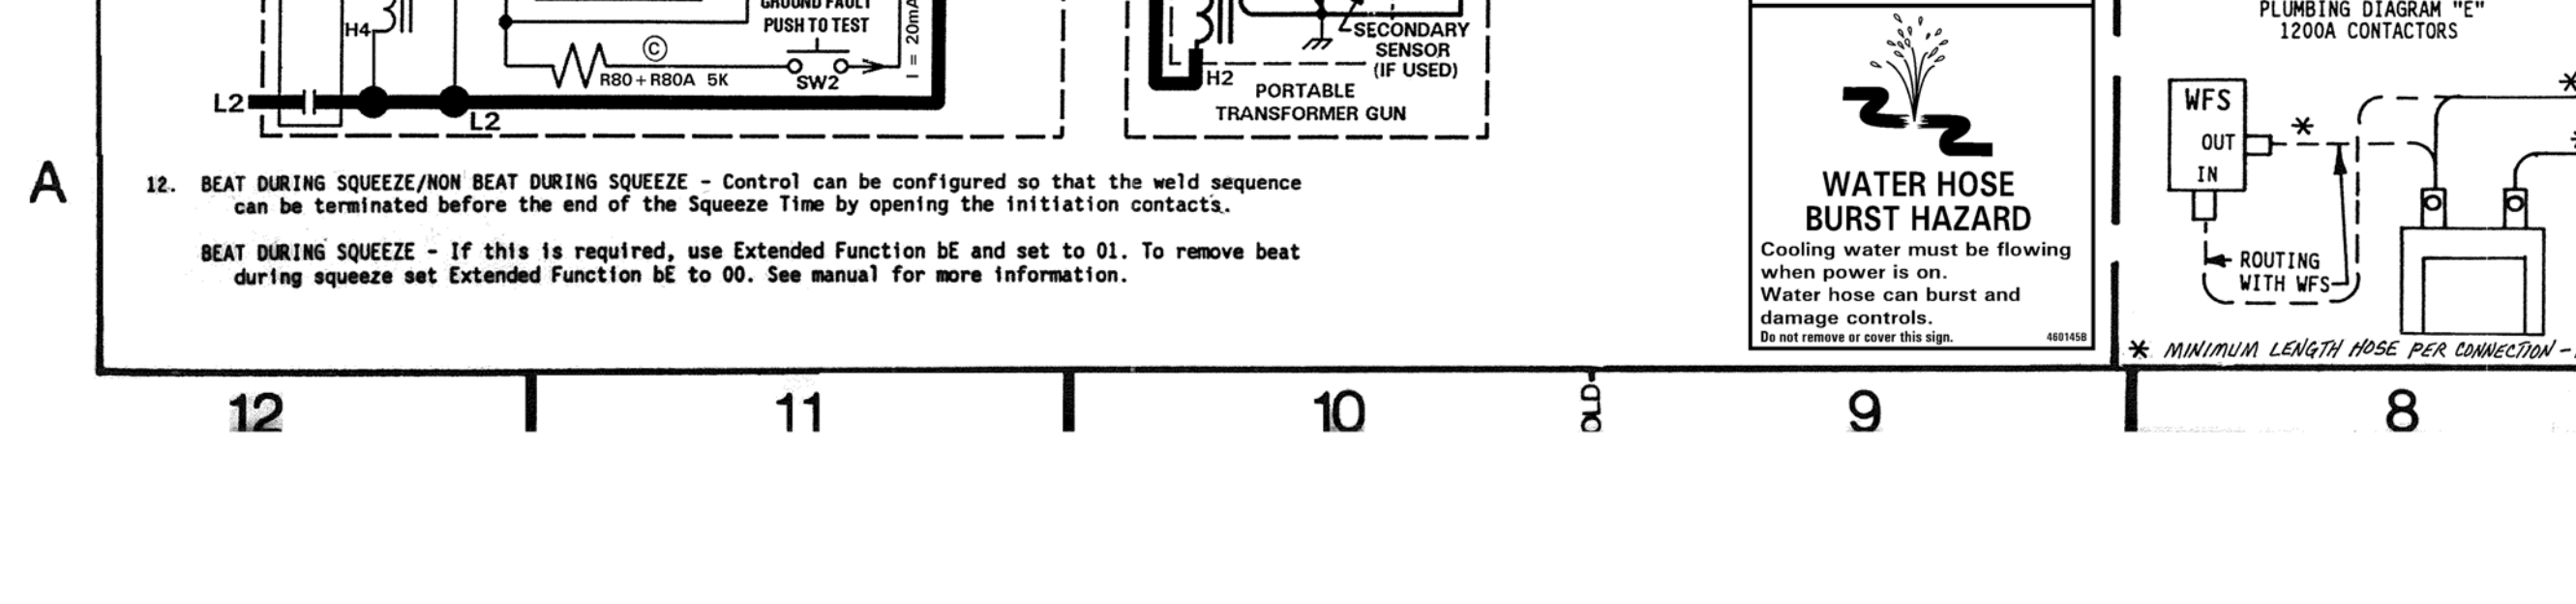

NOTICE: This weld control complies with the RWMA bulletin 5.015.68.04 for use with a hand-held transgun. Includes a table with columns for REV, AUTH, DESCRIPTION, SCALE, DATE, DRAWN BY, CHK'D BY, APPROVED BY. Includes ENTRON CONTROLS INC logo and contact information.